
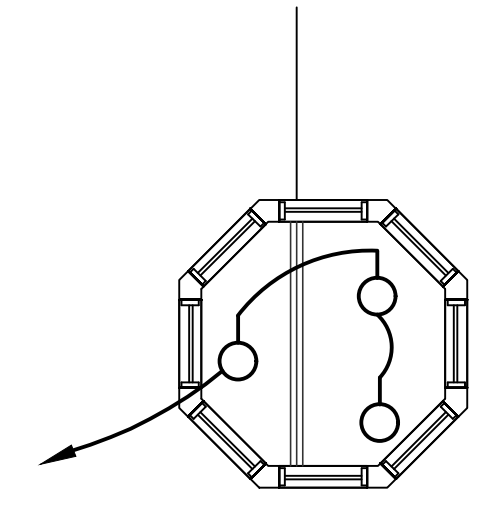


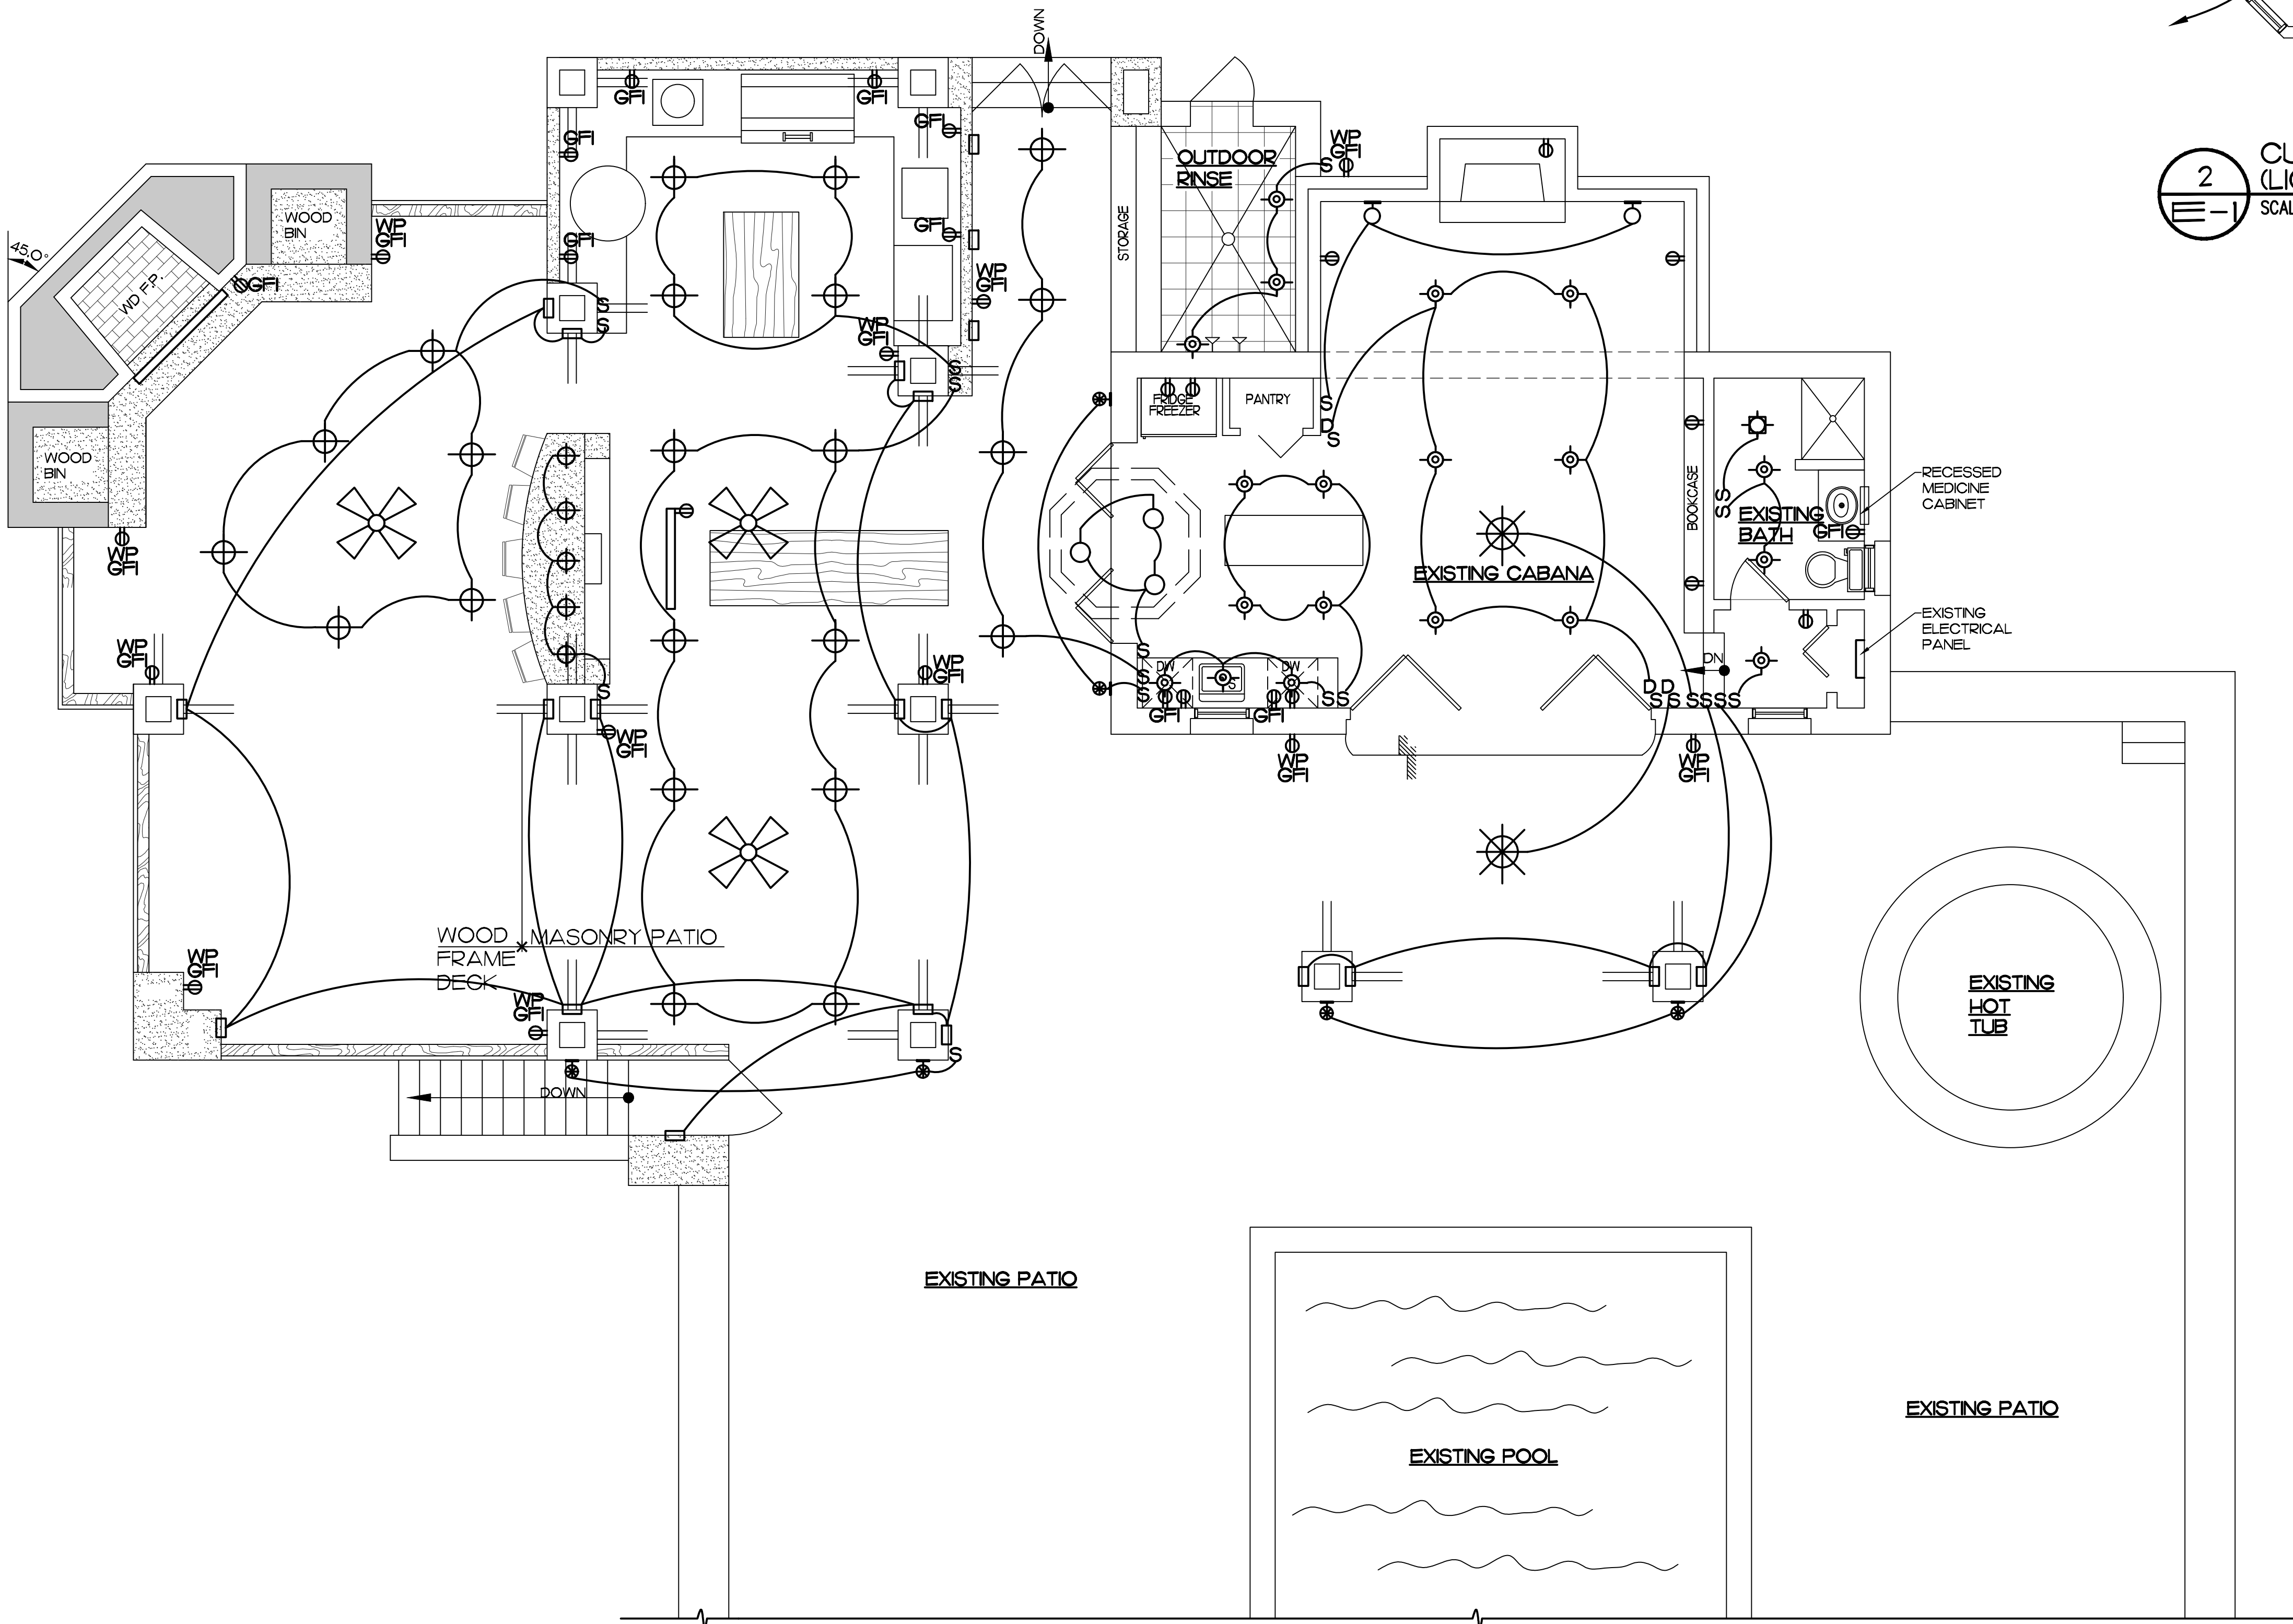

2 CUPOLA PLAN (LIGHT WELL)
SCALE: 1/4"=1'-0"


1 ELECTRICAL FLOOR PLAN
SCALE: 1/4"=1'-0"

LEGEND

- CHANDLER
- CEILING FAN W/LIGHT (REMOTE)
- RECESSED LIGHT
- COACH LIGHT
- OUTLET
- GROUND FAULT PROOF OUTLET
- FOOT LIGHTS
- MEDIUM PENDANT LIGHT
- SMALL PENDANT LIGHT
- FLAT SCREEN TV WITH MOUNTING BRACKETS AND REMOTE - RATED FOR EXPOSURE TO THE WEATHER
- UP LIGHTS AT CUPOLA
- SCONCE
- BATHROOM LIGHT & VENT
- DIMMER SWITCH
- TWO WAY SWITCH
- STORAGE ROOM SURFACE MOUNTED LIGHT

NOTE:
OWNER, G.C., AND ELECTRICIAN SHALL CONDUCT A WALK THROUGH WHEN PROJECT IS ROUGH FRAMED TO DETERMINE FINAL LOCATION OF ALL SWITCHES, LIGHTS, OUTLETS, CEILING FANS, ETC. PRIOR TO ELECTRICIAN INSTALLING 'ROUGHING' FANLIGHTS, REMOTELY SWITCHED AT EACH FAN

PHILLIP CERADINI ARCHITECT
120 KISCO AVENUE
MT. KISCO, NEW YORK
10549 914-666-0547
WWW.PHILLIPCERADINI.COM

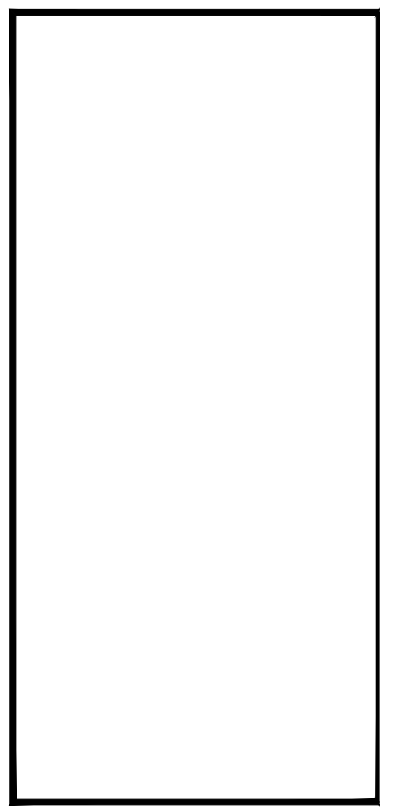

SHEET TITLE
ELECTRICAL FLOOR PLAN
PROJECT TITLE
PROPOSED OUTDOOR KITCHEN GRILLE
AND EXISTING POOL CABANA
GARTHE / VARGAS
13 TAVANO ROAD OSSING, NEW YORK

SCALE:
DSGN/DRFM:
PH 1 APPR'D.:
PH 2 APPR'D.:
PH 3 APPR'D.:
CK'D BY:
CAD #:
PRINT DATE:

SHEET No.
E-1