


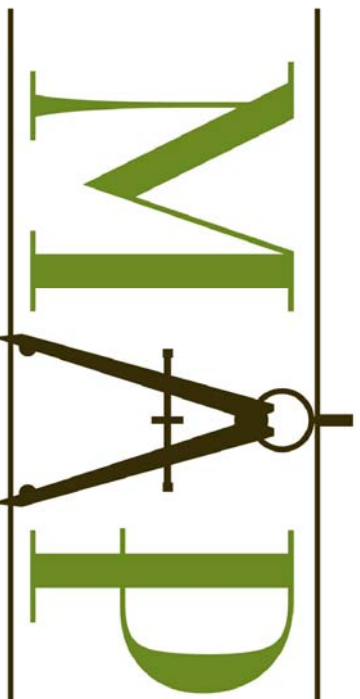

Michael Piccirillo Architecture

NOTE: SCALE DRAWINGS. REFER TO WRITTEN SPECIFICATIONS FOR ACCURACY. OR CONTACT ARCHITECT FOR DETAILS. UNAUTHORIZED ALTERATIONS OR ADDITIONS TO THIS DRAWING IS A VIOLATION OF NEW YORK STATE EDUCATION LAW.
© Copyright 2010 MICHAEL PICCIRILLO ARCHITECTURE

WALL AND DOOR SYMBOLS

- EXISTING WALL TO REMAIN
NEW WALLS TO BE CONSTRUCTED
SEE BUILDING SECTION FOR DETAILS
- EXISTING DOOR TO REMAIN.
- NEW DOOR TO BE INSTALLED
- NEW CONCRETE FOUNDATION WALL
- EXISTING FOUNDATION WALL TO REMAIN
- EXISTING WALL TO BE REMOVED

NO.	DATE:	ISSUE:


PROJECT NAME:

BODANSKY RESIDENCE

RENOVATION / ADDITION

PROJECT ADDRESS:

60 STORMTOWN ROAD
OSSINING, NY 10562

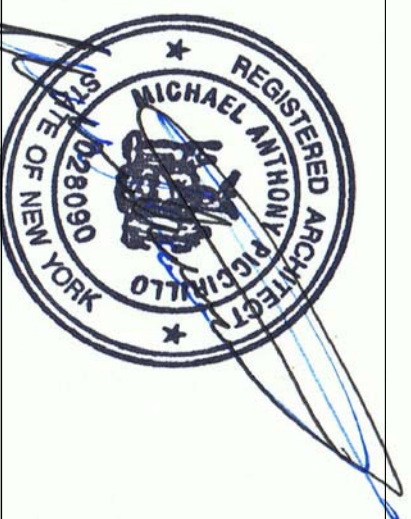

MICHAEL A PICCIRILLO, AIA

345 KEAR STREET

YORKTOWN HEIGHTS, NEW YORK 10598

TELEPHONE: 914-368-9838

FACSIMILE: 914-302-2933

michael@mpiccirilloarchitect.com

www.mpiccirilloarchitect.com

FIRST FLOOR PLAN

SCALE: AS NOTED DATE: 06-12-24

DRAWN BY: MAP

CHECKED BY: MAP

A-101

SECTION 07200 - INSULATION

- FIBERGLASS BLANKET INSULATION FOR NEW AND ACCESSIBLE FRAMED AREAS. INSTALL FIBERGLASS BLANKETS IN ALL WALL CAVITIES, INCLUDING CAVITIES AROUND WINDOWS, STAIR OVERLAPPED FLANGES OF FACED BLANKET INSULATION SECURELY TO WOOD FRAMING MEMBERS. KRAFT FACING TO BE ON VAPOR SIDE.
- FORMED POLYSTYRENE BATTLES FOR ATTIC/CEILING RAFTER CAVITIES. INSTALL FORMED POLYSTYRENE BATTLES (PROPAVANT OR RAFTERMATE) AT UNDERSIDE OF ROOF SHEATHING IN ALL ROOF/CEILING RAFTER CAVITIES TO FACILITATE PROPER AIR FLOW.
- FIBERGLASS BLANKETS TO BE 6" THICK (R-21) IN ALL EXTERIOR WALLS. BLANKETS TO BE KRAFT PAPER FACED. KRAFT FACING TO BE ON WARM SIDE.
- FIBERGLASS BLANKETS TO BE 9" THICK (R-38C) IN ATTICS AND FLOORS. BLANKETS TO BE KRAFT FACED
- FIBERGLASS ACOUSTICAL ATTENUATION BLANKETS 6 1/2" TO BE INSTALLED IN ALL INTERIOR WALLS AS SHOWN AND CEILINGS. BLANKETS TO BE UNFACED WITH NO VAPOR BARRIER.


ELECTRICAL PLAN NOTES:

ALL RECESSED LIGHTS TO BE LED
ALL LIGHTS TO BE ON DIMMERS

- ALL SURFACE MOUNTED WALL AND CEILING LIGHT FIXTURES SHALL BE PURCHASED BY THE OWNER AND COORDINATED AND INSTALLED BY CONTRACTOR.
- ALL SMOKE DETECTORS SHALL BE TANDEN HARD WIRED SUCH THAT WHEN ONE SOUNDS, ALL WILL SOUND PER NATIONAL ELECTRICAL CODE, LOCAL CODE, NFPA 72.
- EXACT LOCATIONS OF ALL LIGHT FIXTURES SHALL BE REVIEWED WITH THE OWNER ON SITE PRIOR TO INSTALLATION. ELECTRICAL OUTLETS SHALL INSTALLED TO MATCH EXISTING, EXCEPT FOR AT COUNTERTOPS, VANITIES, AND AS OTHERWISE NOTED.
- ALL ELECTRICAL WORK SHALL BE IN COMPLIANCE WITH APPLICABLE CODES. THE CONTRACTOR SHALL BE RESPONSIBLE FOR OBTAINING NECESSARY PERMITS AND FOR OBTAINING CERTIFICATE FROM THE NEW YORK STATE BOARD OF FIRE UNDERWRITERS.
- CONTRACTOR SHALL PROVIDE RECEPTACLES / POWER TO ALL MAJOR APPLANCES AS REQUIRED. TYPE, QUANTITY, AND LOCATIONS SHALL BE COORDINATED WITH THE SPECIFIC APPLANCES BEING INSTALLED.
- CONTRACTOR SHALL INSTALL CONVENIENCE OUTLETS IN ALL ROOMS, INCLUDING HALLWAYS AS PER APPLICABLE CODES.
- ALL SWITCHES GROUPED TOGETHER SHALL BE GANGED ON ONE SWITCH PLATE.
- EXTERIOR LIGHTING TO BE ON PHOTOSENSOR SWITCH
- TELEPHONE, FAX, COMPUTER, TELEVISION, AND OTHER COMMUNICATION WIRING TO BE LOCATED IN FIELD WITH THE OWNER.
- ALL SWITCHES TO BE DIMMERS, TYPICAL. U.O.N., EXCEPT OVER COUNTERTOP
- PROVIDE RECEPTACLES AS SHOWN OR AT MINIMUM CODE REQUIREMENTS
- PROVIDE DEDICATED CIRCUITS FOR MICROWAVE, TOASTER OVEN, ETC
- REFER TO SHEET T-2 FOR FURTHER SPECIFICATIONS


ELECTRICAL LEGEND

220	220 VOLT WALL RECEPTACLE	\$	SINGLE POLE SWITCH
Ex	EXISTING WALL RECEPTACLE	\$3	THREE WAY SWITCH
N	NEW WALL RECEPTACLE	\$4	FOUR WAY SWITCH
CT	WALL RECEPTACLE AT 48" A.F.F.	\$J	JAMB SWITCH
SP	SPEAKER WIRE	NEW 140 CFM EXHAUST FAN BY PANASONIC WITH HUMIDISTAT BY JOHNSON CONTROL.	
WP	WEATHER PROOF GFI	NEW CABLE TELEVISION RECEPTACLE	
4	4 OUTLET (QUAD) RECEPTACLE	NEW TELEPHONE (2 LINES)	
GFI	GROUND FAULT RECEPTACLE (GFI)	STRIP FLUORESCENT (SINGLE BULB)	
GF	RECESSED LIGHT FIXTURE	CARBON MONOXIDE DETECTOR	
Lv	LOW VOLTAGE RECESSED	SMOKE DETECTOR HARD WIRED WITH BATTERY BACKUP	
WP	IN WET AREA	HEAT DETECTOR	
S	SURFACE MOUNTED LIGHT FIXTURE	2 BULB FLUORESCENT FIXTURE	
OL	WALL MOUNTED LIGHT FIXTURE	4-0" LONG FIXTURE	
Porc	WALL MOUNTED LIGHT FIXTURE WITH LENSE, IN CLOSET	NEW DOOR BELL	
SC	SCONCE	CEILING MOUNTED FAN WITH LIGHT KIT	
W	WALL WASHER		
Ex	EXTERIOR WALL MOUNTED LIGHT FIXTURE		

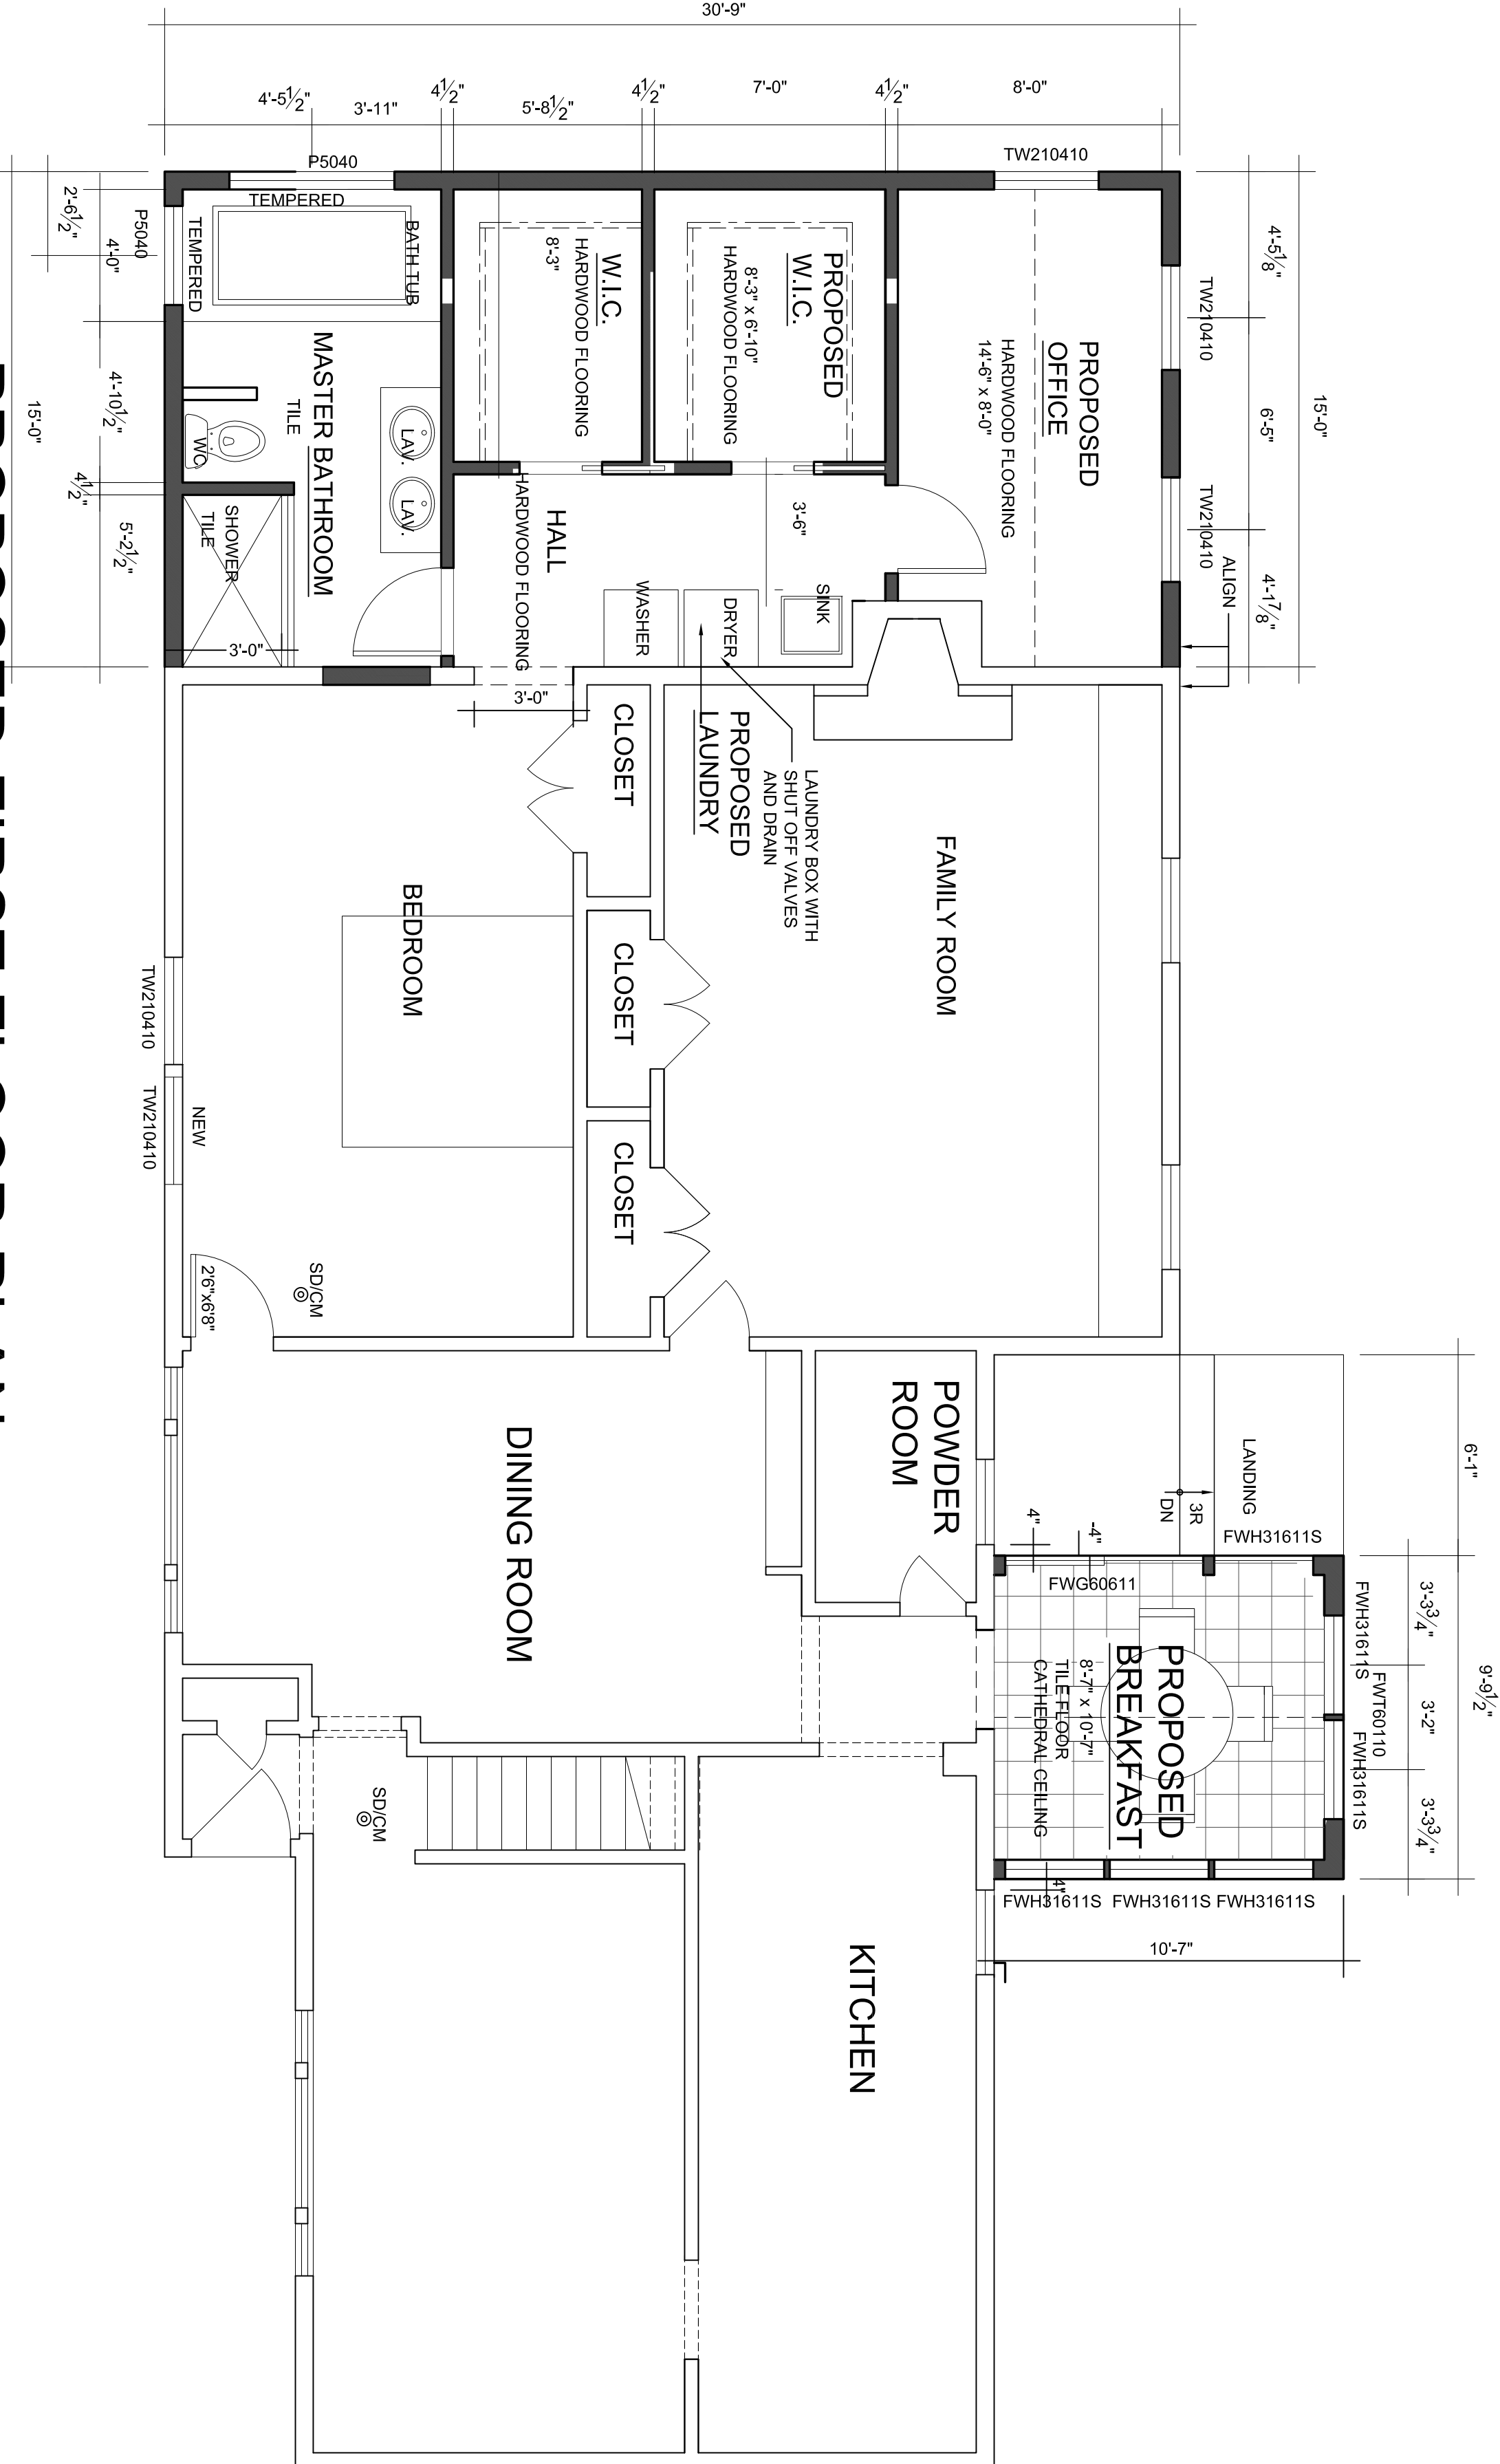

PROPOSED FIRST FLOOR PLAN

A SCALE: 1/4" = 1'-0"

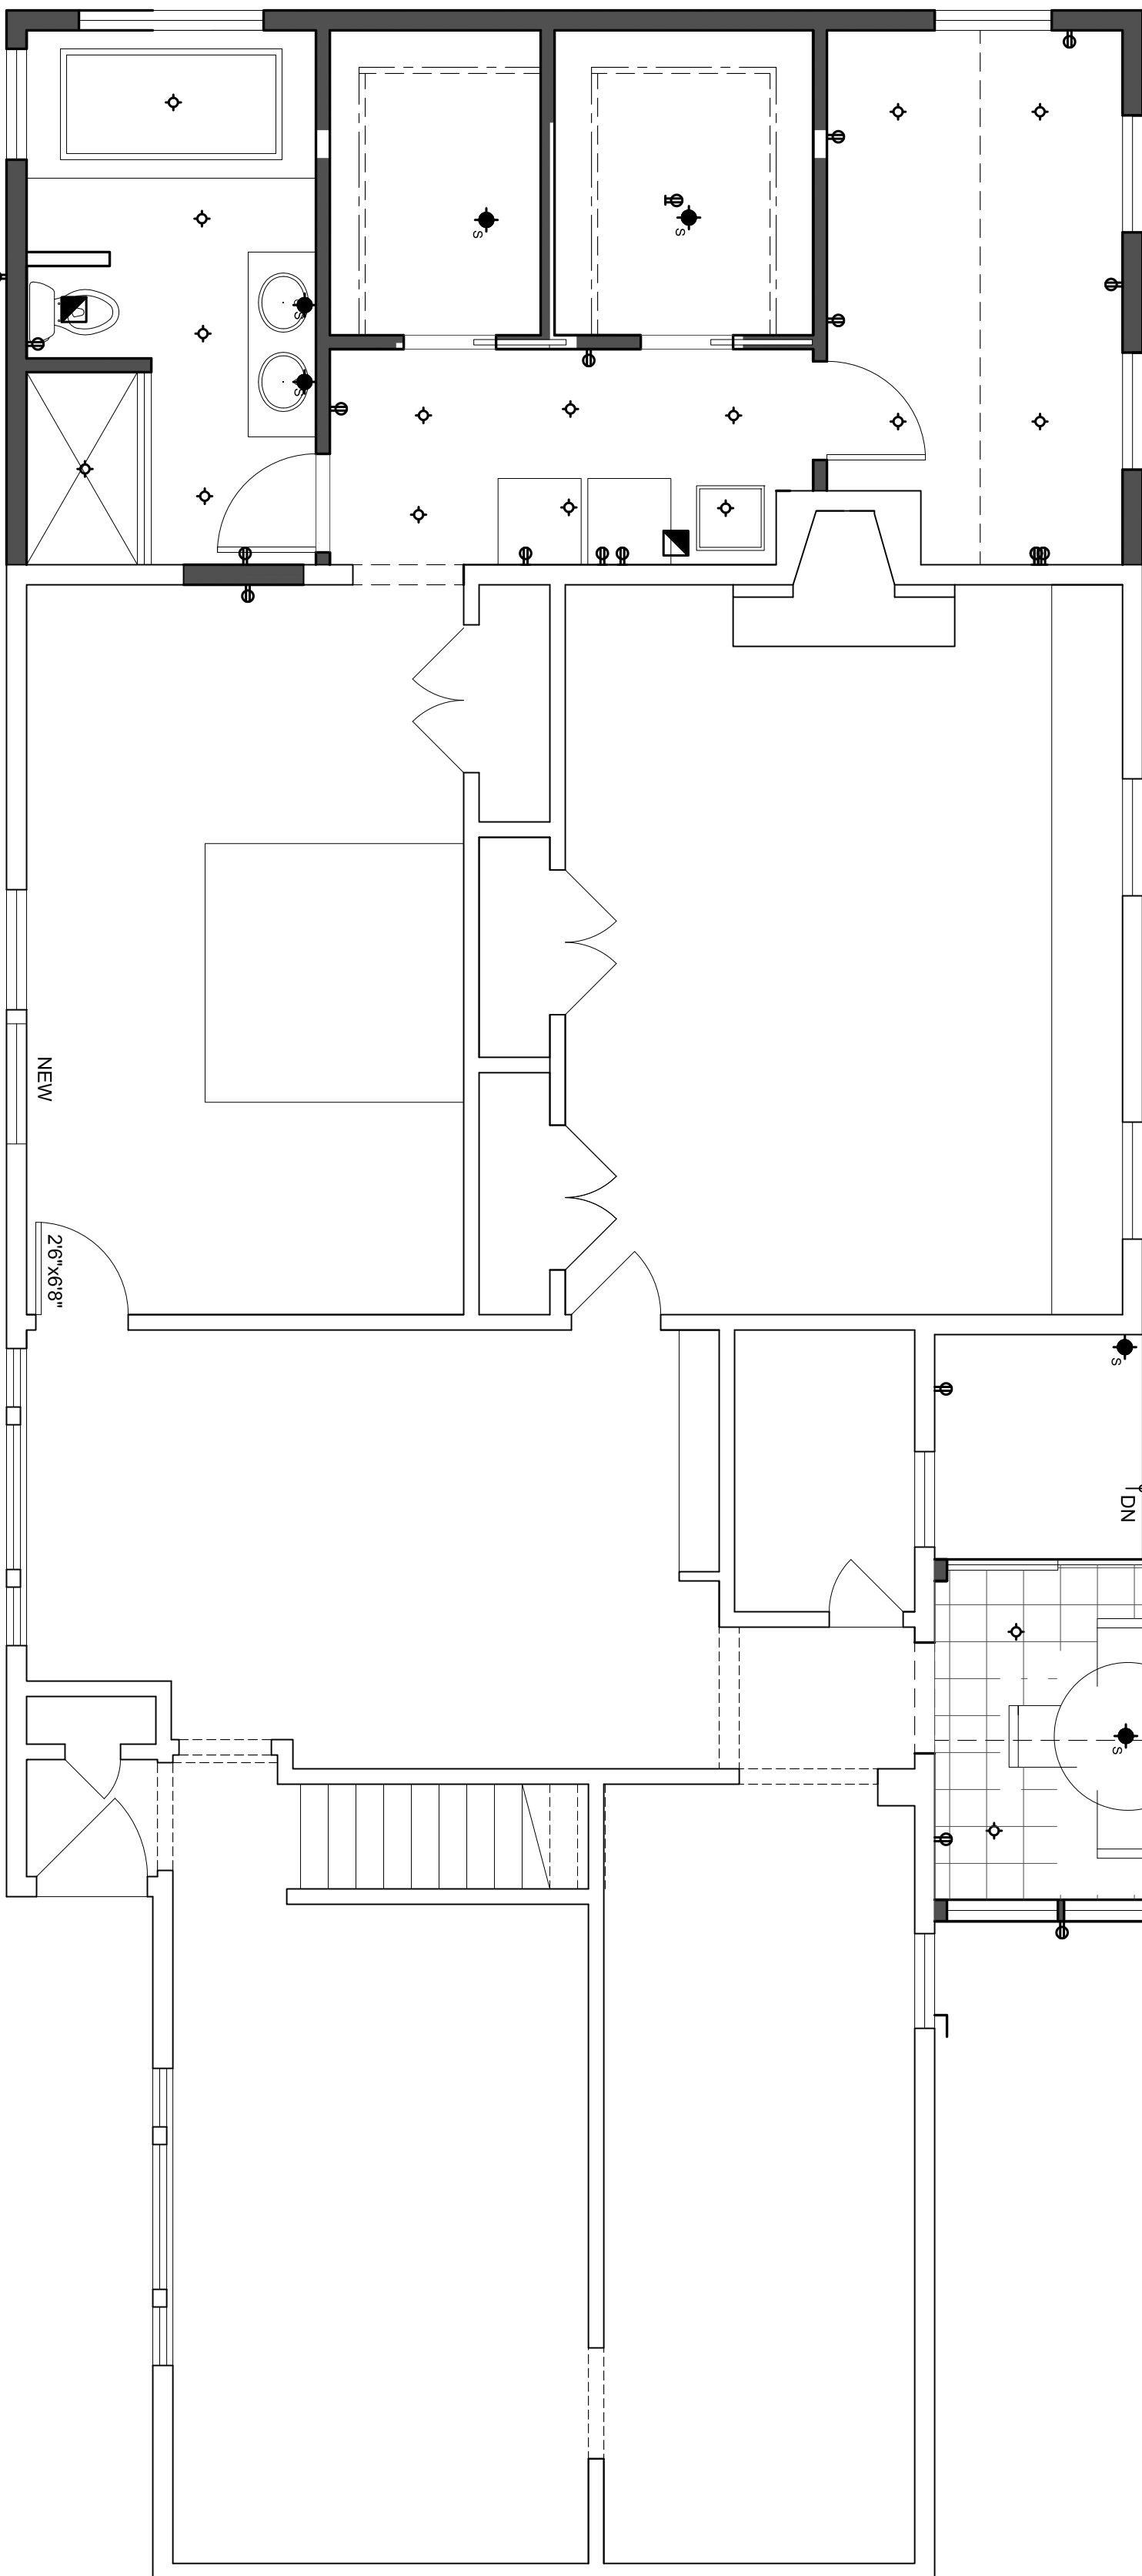

ELECTRICAL FLOOR PLAN

B SCALE: 1/4" = 1'-0"